


# WILLOWBANK CRESCENT

# WILLOWBANK CRESCENT

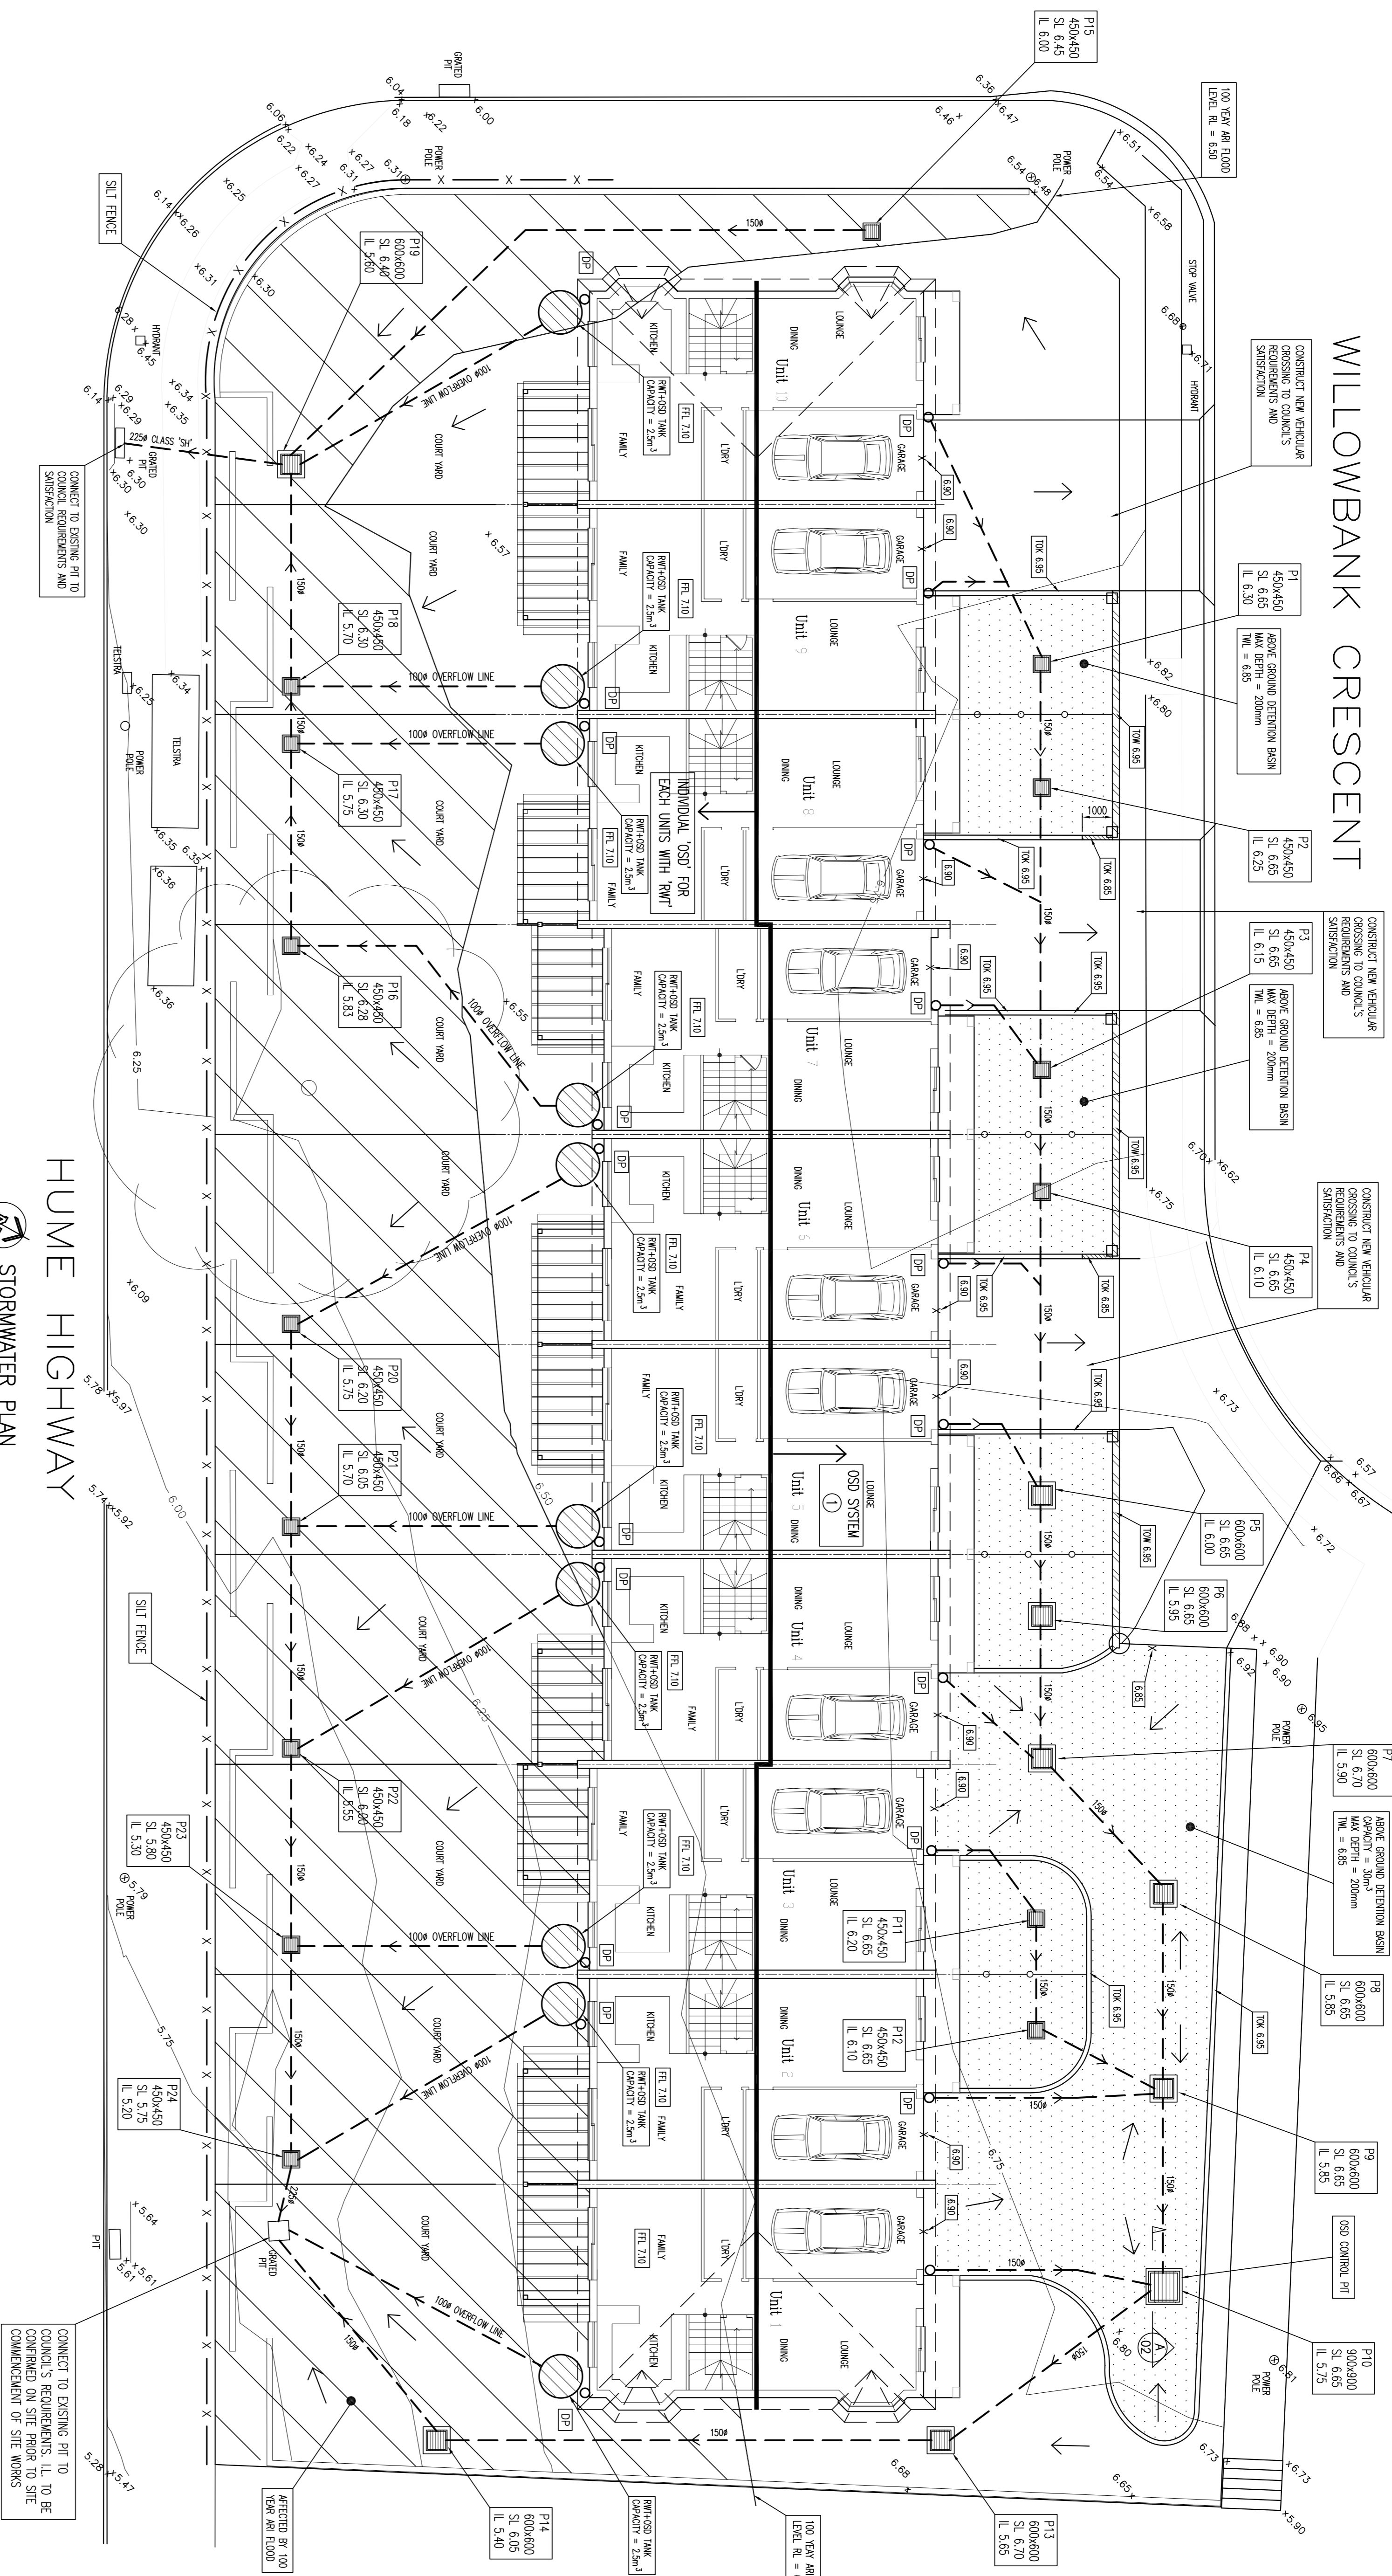

### NOTES:-

1. ALL WORKS TO BE CONSTRUCTED TO THE REQUIREMENTS AND SATISFACTION OF FAIRFIELD CITY COUNCIL.
2. PRIOR TO COMMENCEMENT OF ANY SITE WORKS, THE BUILDER/PLUMBER IS TO EXPOSE ALL SERVICES IN THE FULL WIDTH OF THE FOOTPATH TO ENSURE THERE ARE NO OBSTRUCTIONS IN THE LINE OF THE DRAINAGE DISCHARGE PIPE.
3. THE DRAINAGE CONTRACTOR IS TO LOCATE AND RELOCATE AS NECESSARY ALL SERVICES ON SITE.
4. THE BUILDER IS TO VERIFY ALL LEVELS ON THE SITE PRIOR TO COMMENCING CONSTRUCTION.
5. SILT FENCE IS TO BE ERECTED PRIOR TO COMMENCING WORK. FENCE TO BE MAINTAINED IN WORKING ORDER DURING THE TIME OF CONSTRUCTION.
6. W.A.E. DRAWING BY A REGISTERED SURVEYOR IS REQUIRED PRIOR TO CERTIFICATION OF DRAINAGE.
7. U.N.O. ALL DOWN PIPES ARE TO BE 100X70.
8. U.N.O. ALL PIPES TO BE 100# CLASS 'SH' WITH 1% MIN SLOPE.

## HUME HIGHWAY

### STORMWATER PLAN

SCALE:- 1:100 @ B1

### LEGEND:-

DOWN PIPE	ODP	DRAINAGE LINE	---
RETAINING WALL	▨	SURFACE INLET PIT	▭
TOW - TOP OF WALL	—	AGG. LINE	—○—○—○—
I.L. - INNER LEVEL	—	SILT FENCE	—X—X—
S.L. - SURFACE LEVEL	—	EXISTING LEVEL	—
S.H. - SEWER HEAVY	—●—	DESIGN LEVEL	—
CLEANING EYE	—	DIRECTION OF NATURAL WATER FLOW	←
SPREADER PIPE	—SP		

Engineer	N. LOGESMARAN BscEng, Grad.Dip.Eng, MEng, MEngStud, MEAust, CPeng, NPER Mobile: 0401 132 366 18/40 WIGRAM STREET, HARRIS PARK, NSW 2150
Issue	ISSUED FOR APPROVAL
Issue	ISSUED FOR INFORMATION
Date	29.11.07
Date	3.12.07
Date	29.11.07

ST	ST
ST	ST
ST	ST

Drawing Title:	STORMWATER DRAINAGE LAYOUT PLAN
----------------	---------------------------------

DESIGNED	N.L.
DRAWN	S.T.
DATUM	AHD
DATE	29.11.07

Project:	TERRACE HOUSE DEVELOPMENT 61 HUME HIGHWAY LANSVALE
----------	--

Ref No.:	071129-01
Issue:	B
SHEET	1 of 2